


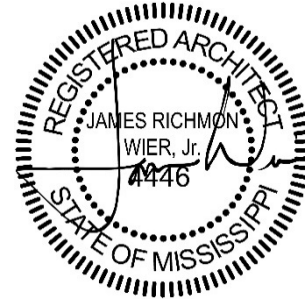

26 June 2020

Richland Parks and Recreation Building | City of Richland  
WBA Project No. 2619



---

## ADDENDUM NO. 01

### NOTICE TO ALL DOCUMENT HOLDERS:

The following additions, deletions, changes and clarifications to the drawings and specifications are to be included as part of the Contract Documents.

### SPECIFICATIONS

- ITEM NO. 01**      **SECTION 00.1113**  
**DELETE** 1.3.E - Bid Documents may be viewed at [centralauctionhouse.com](http://centralauctionhouse.com). For any questions relating to the electronic bidding process, please call Central Bidding at 225-810-4814. Removes all requirements for electronically submitted bids.
- ITEM NO. 02**      **SECTION 00.2113**  
**DELETE** 2.1.B - Electronically submitted bids to be received before 10:00 a.m. local standard time on the 17th day of July, 2020. Removes all requirements for electronically submitted bids.

### DRAWINGS

- ITEM NO. 03**      **SHEET E1.3 SOCCER FIELDS**  
**DELETE** sheet in its entirety and **REPLACE** with enclosed sheet. **ADD** lighting system notes.

Encl:    Drawings (24x36):  
          E1.3 SOCCER FIELDS

cc:        All Document Holders  
          File 2619.C2

GENERAL NOTES	
Mark	Description
1.	POLE FOUNDATION DESIGN SHALL BE BY LIGHTING VENDOR'S MISSISSIPPI LICENSED STRUCTURAL ENGINEER.
2.	PROVIDE QUAZITE PULLBOXES AS NEEDED SO THAT TOTAL BENDS SHALL NOT EXCEED 360 DEGREES.
3.	DO NOT ROUTE CONDUITS UNDER THE FIELDS OR THE TRACK.
4.	MUSCO ATHLETIC FIELD LIGHTING POLES AND CIRCUITRY SHALL BE INSTALLED AS PART OF THE BASE BID. ALL SUBSTITUTE ATHLETIC FIELD LIGHTING AND POLES SHALL BE SUBMITTED AS ALTERNATE #5.

KEYED NOTES	
Mark	Description
①	EXISTING POLE LIGHT TO REMAIN.

SITE WIRE LEGEND	
Mark	Description
-OHP1-	PROPOSED SINGLE PHASE OVERHEAD PRIMARY
-UGS-	UNDERGROUND SECONDARY

**Lighting System**


Pole / Fixture Summary						
Pole ID	Pole Height	Mtg Height	Fixture Qty	Luminaire Type	Load	Circuit
S1-S4	60'	60'	5	TLC-LED-1200	5.85 kW	A
S5-S8	60'	60'	5	TLC-LED-1200	5.85 kW	B
<b>Σ</b>			<b>40</b>		<b>46.80 kW</b>	


Circuit Summary			
Circuit	Description	Load	Fixture Qty
A	Soccer 1	23.4 kW	20
B	Soccer 2	23.4 kW	20


Fixture Type Summary							
Type	Source	Wattage	Lumens	L90	L80	L70	Quantity
TLC-LED-1200	LED 5700K - 75 CRI	1170W	136,000	>120,000	>120,000	>120,000	40





3 SINGLE LINE DIAGRAM - SOCCER FIELDS  
Scale: NONE

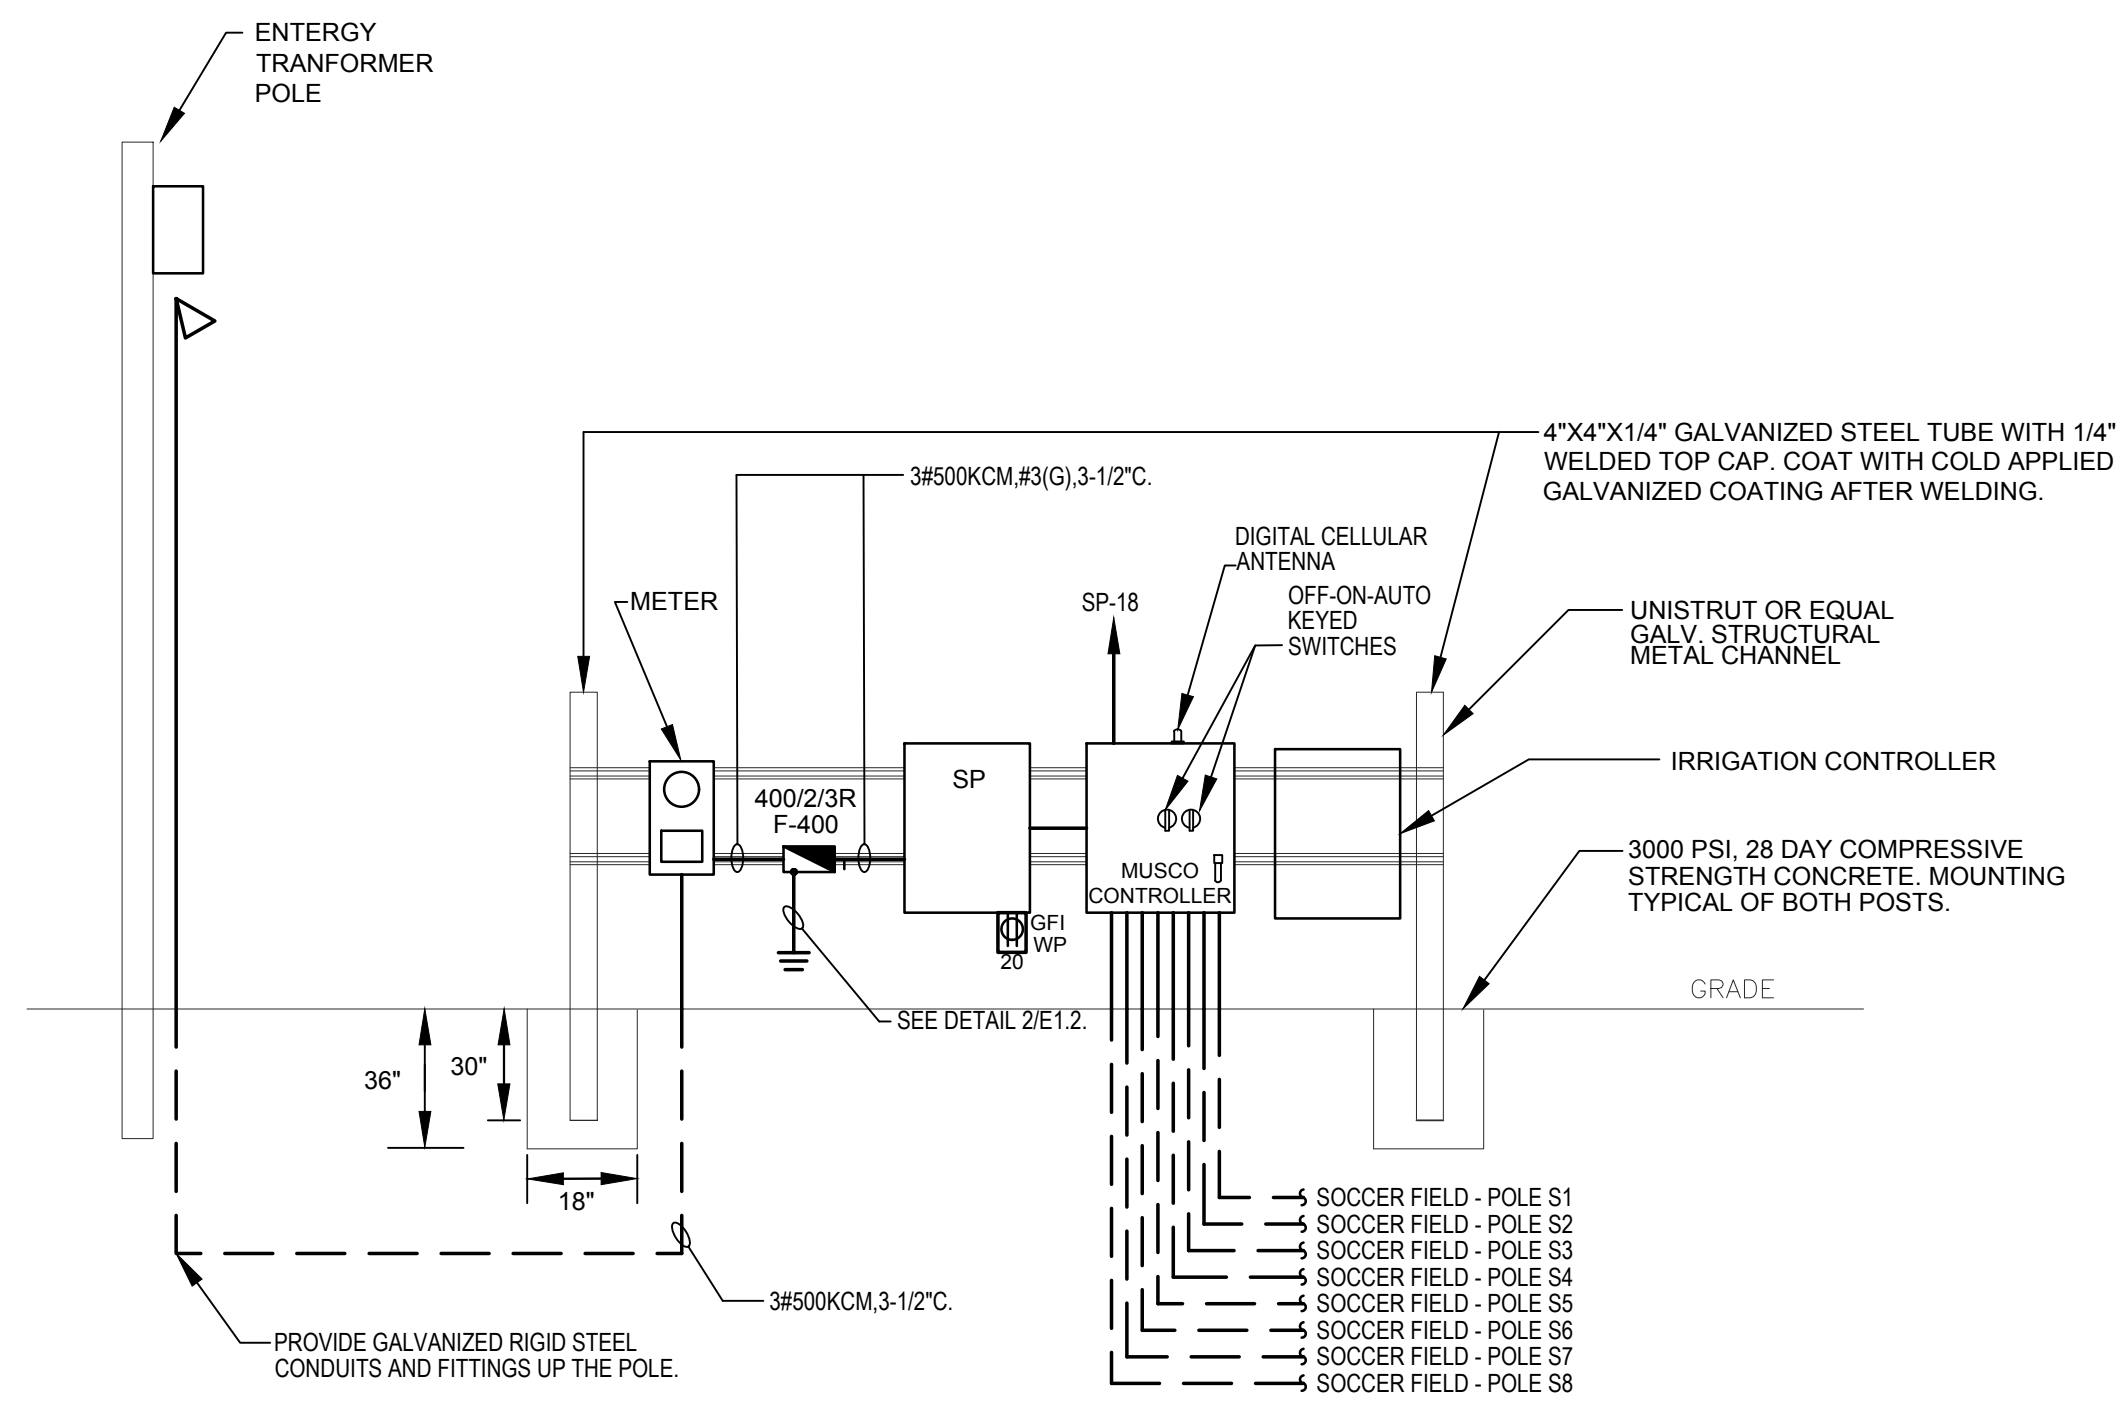

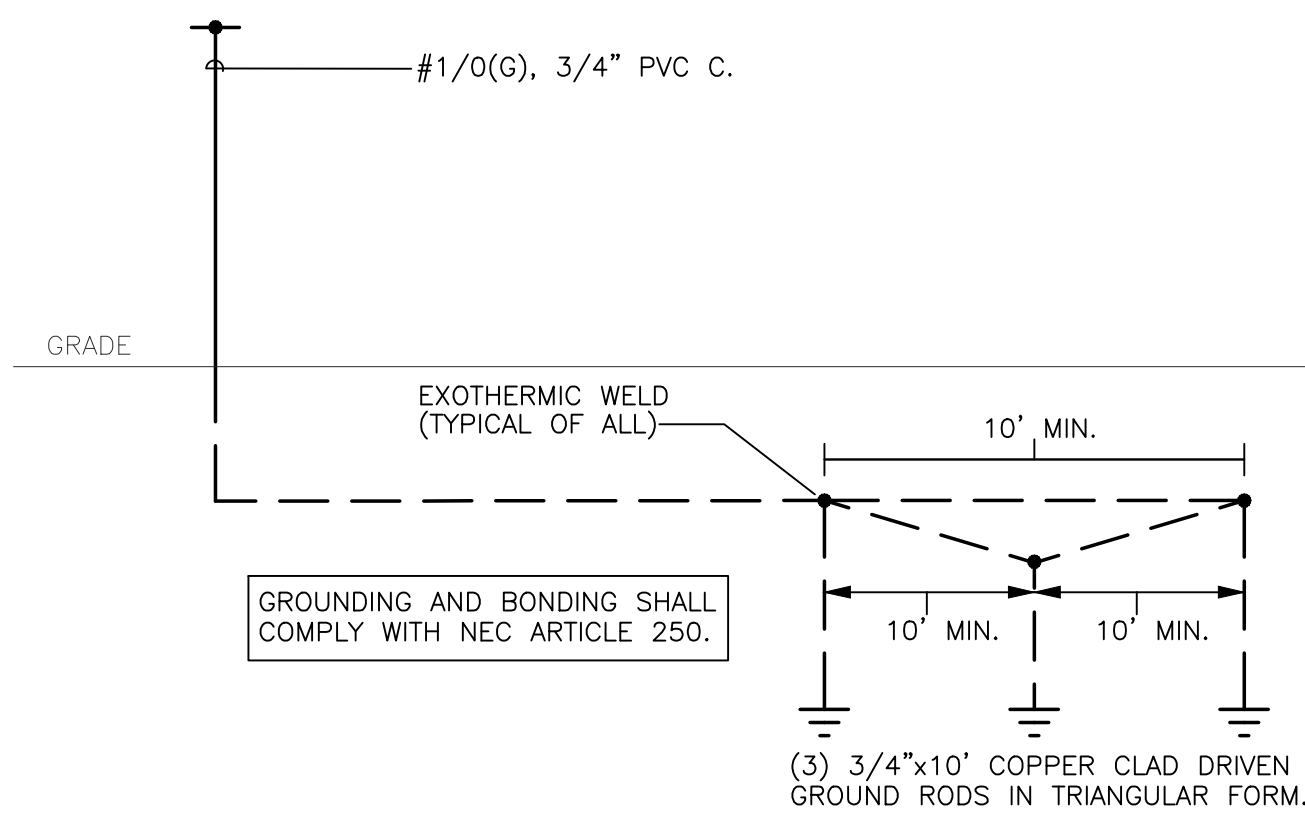2 GROUNDING DETAIL  
Scale: NONE

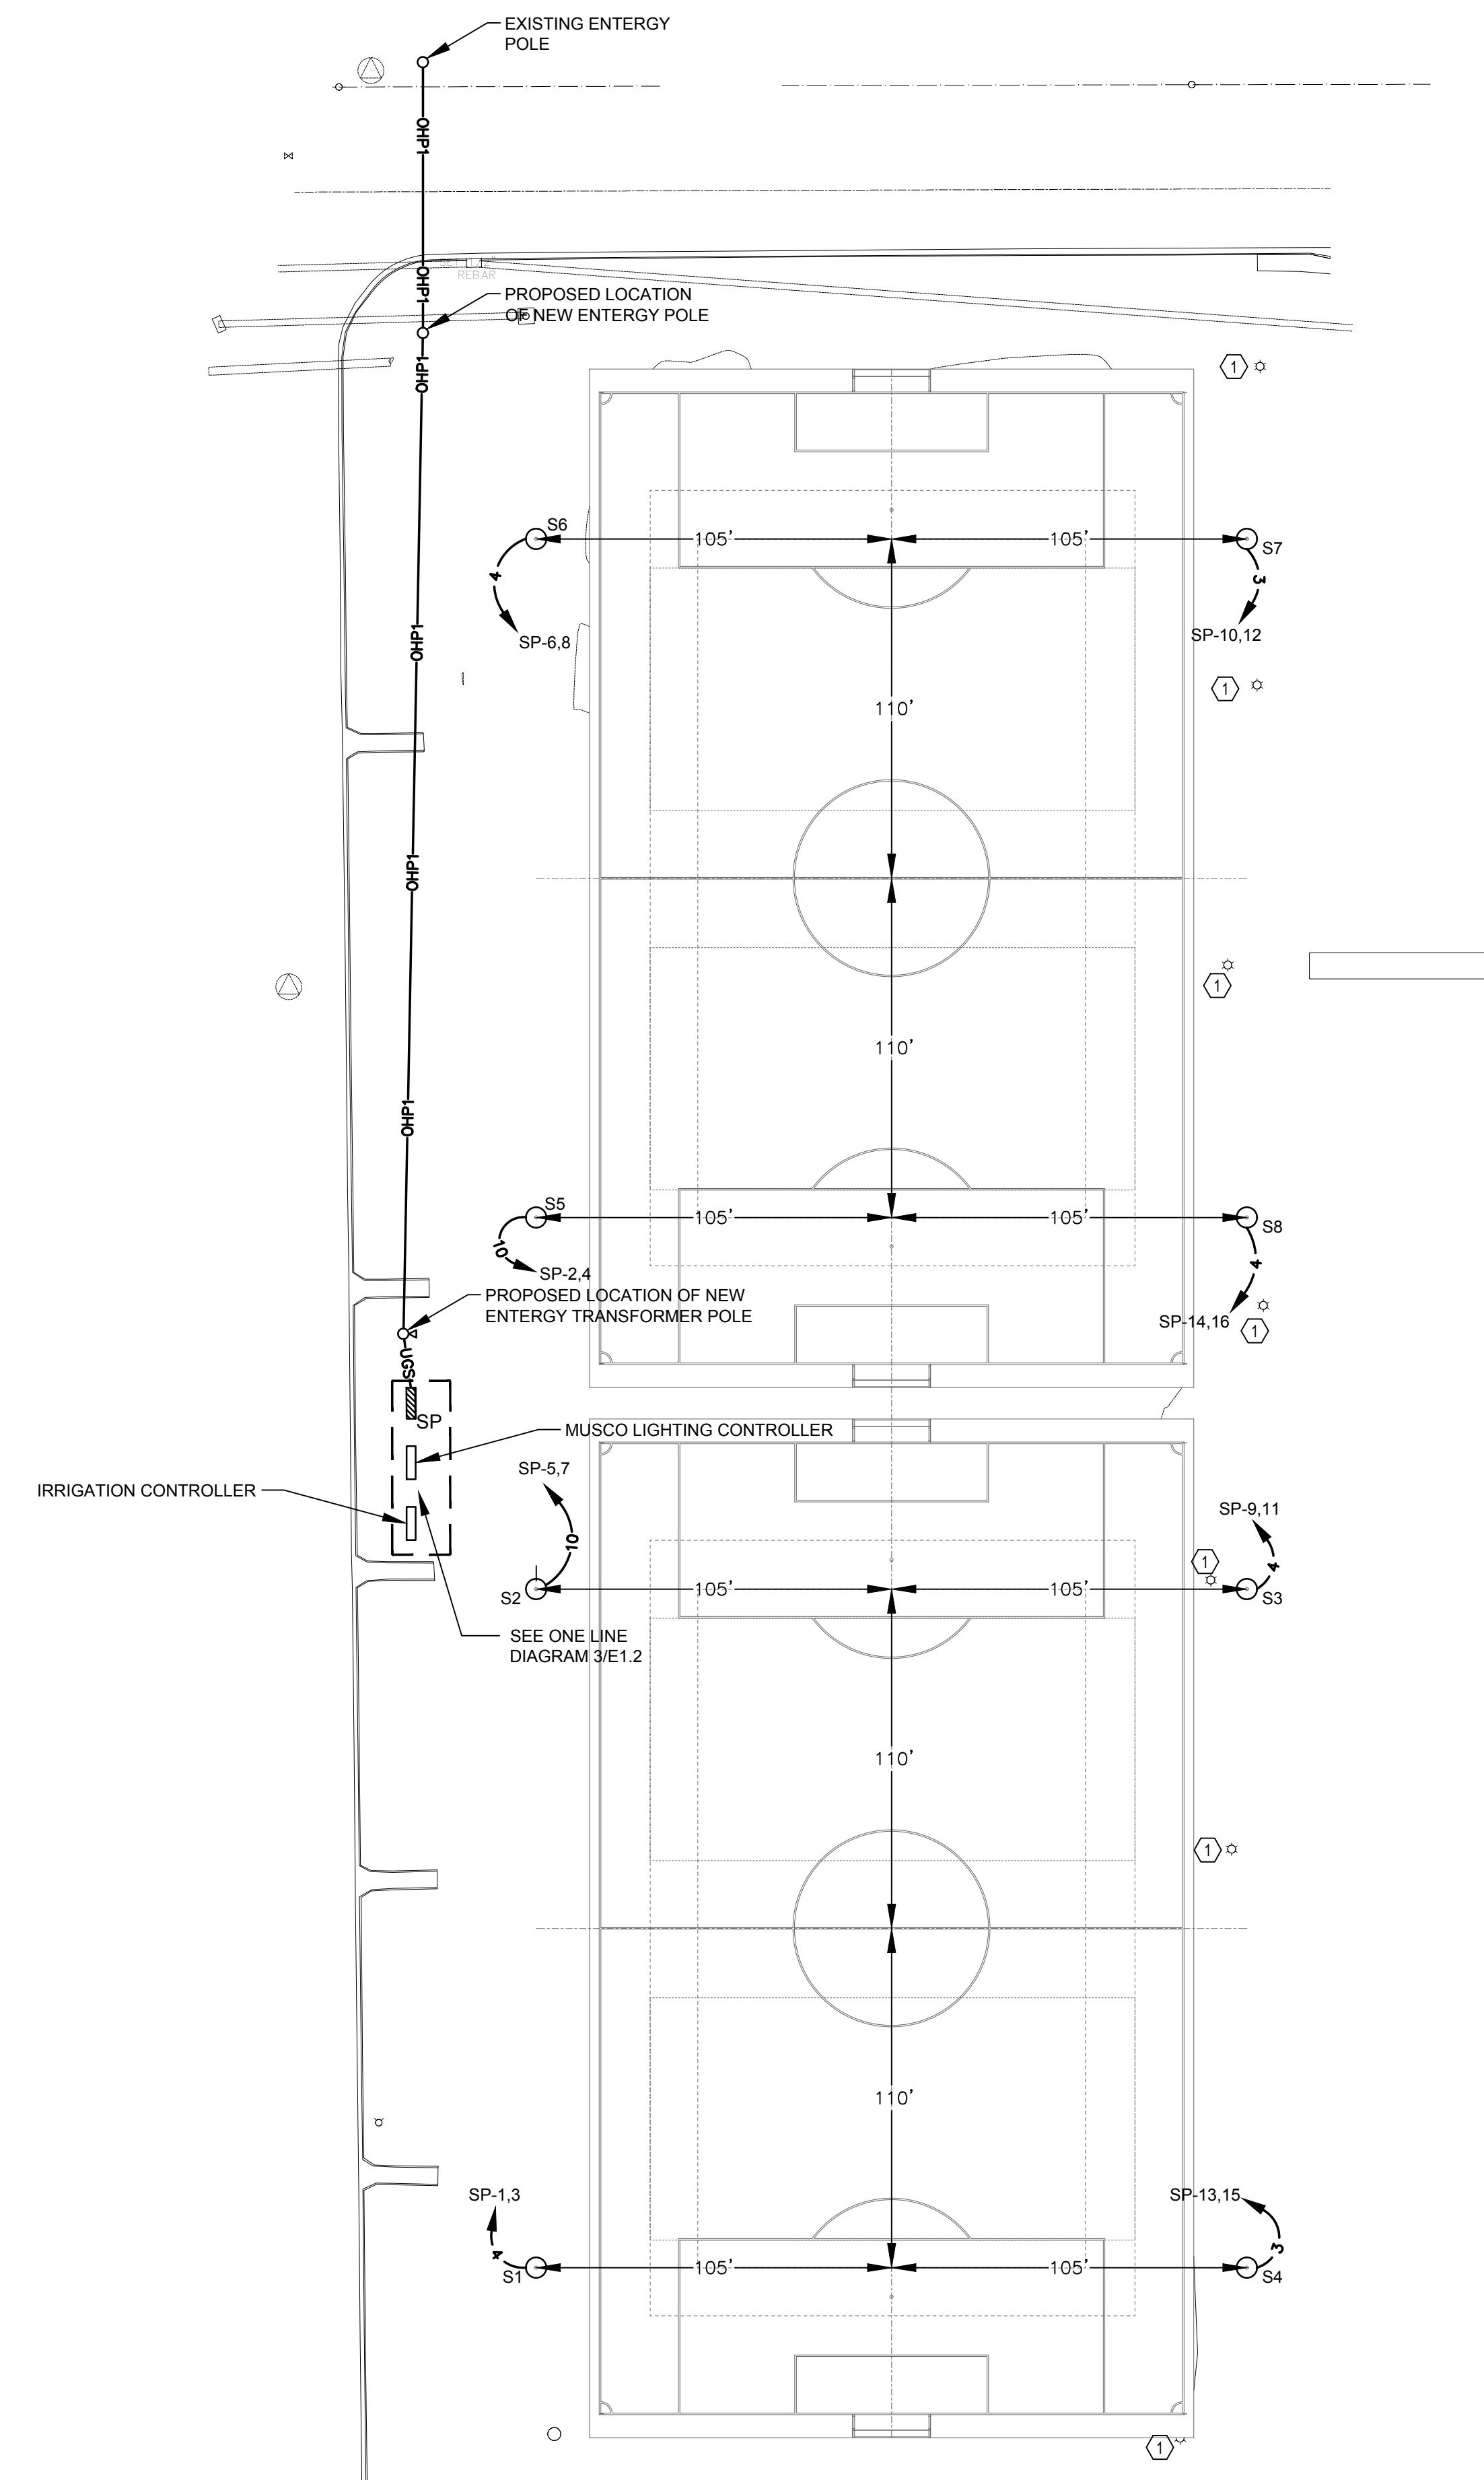

1 LIGHTING PLAN - SOCCER FIELDS  
Scale: 1" = 40'-0"

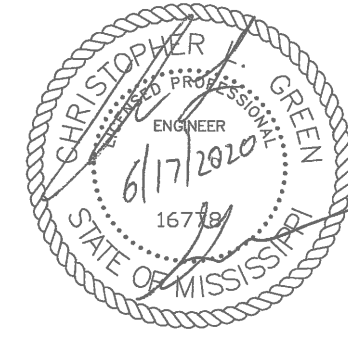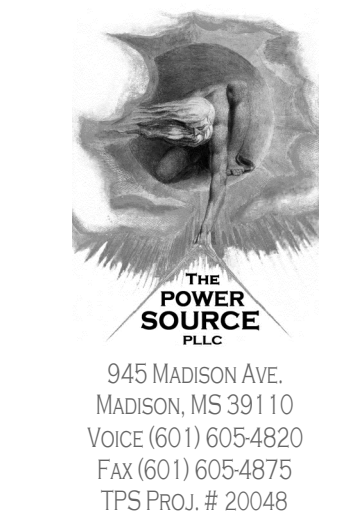

**RICHLAND PARKS AND RECREATION BUILDING**  
CITY OF RICHLAND  
410 E HARPER ST.  
RICHLAND, MS 39218

JUNE 17, 2020

100%  
CONSTRUCTION DOCUMENTS  
WBA # 2619

REVISIONS  
NO. DESCRIPTION DATE  
ADDENDUM #1 06-26-2020

